
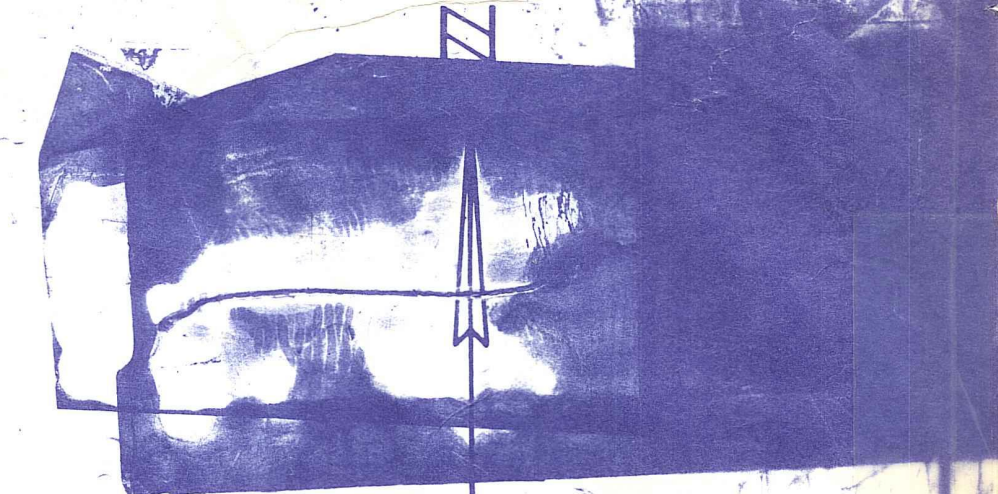


THIS SUB - VILLAGES OF PALM BEACH LAKES - BLK 2 PL 2 PB44 PI
CODED 74-42-43-12-03

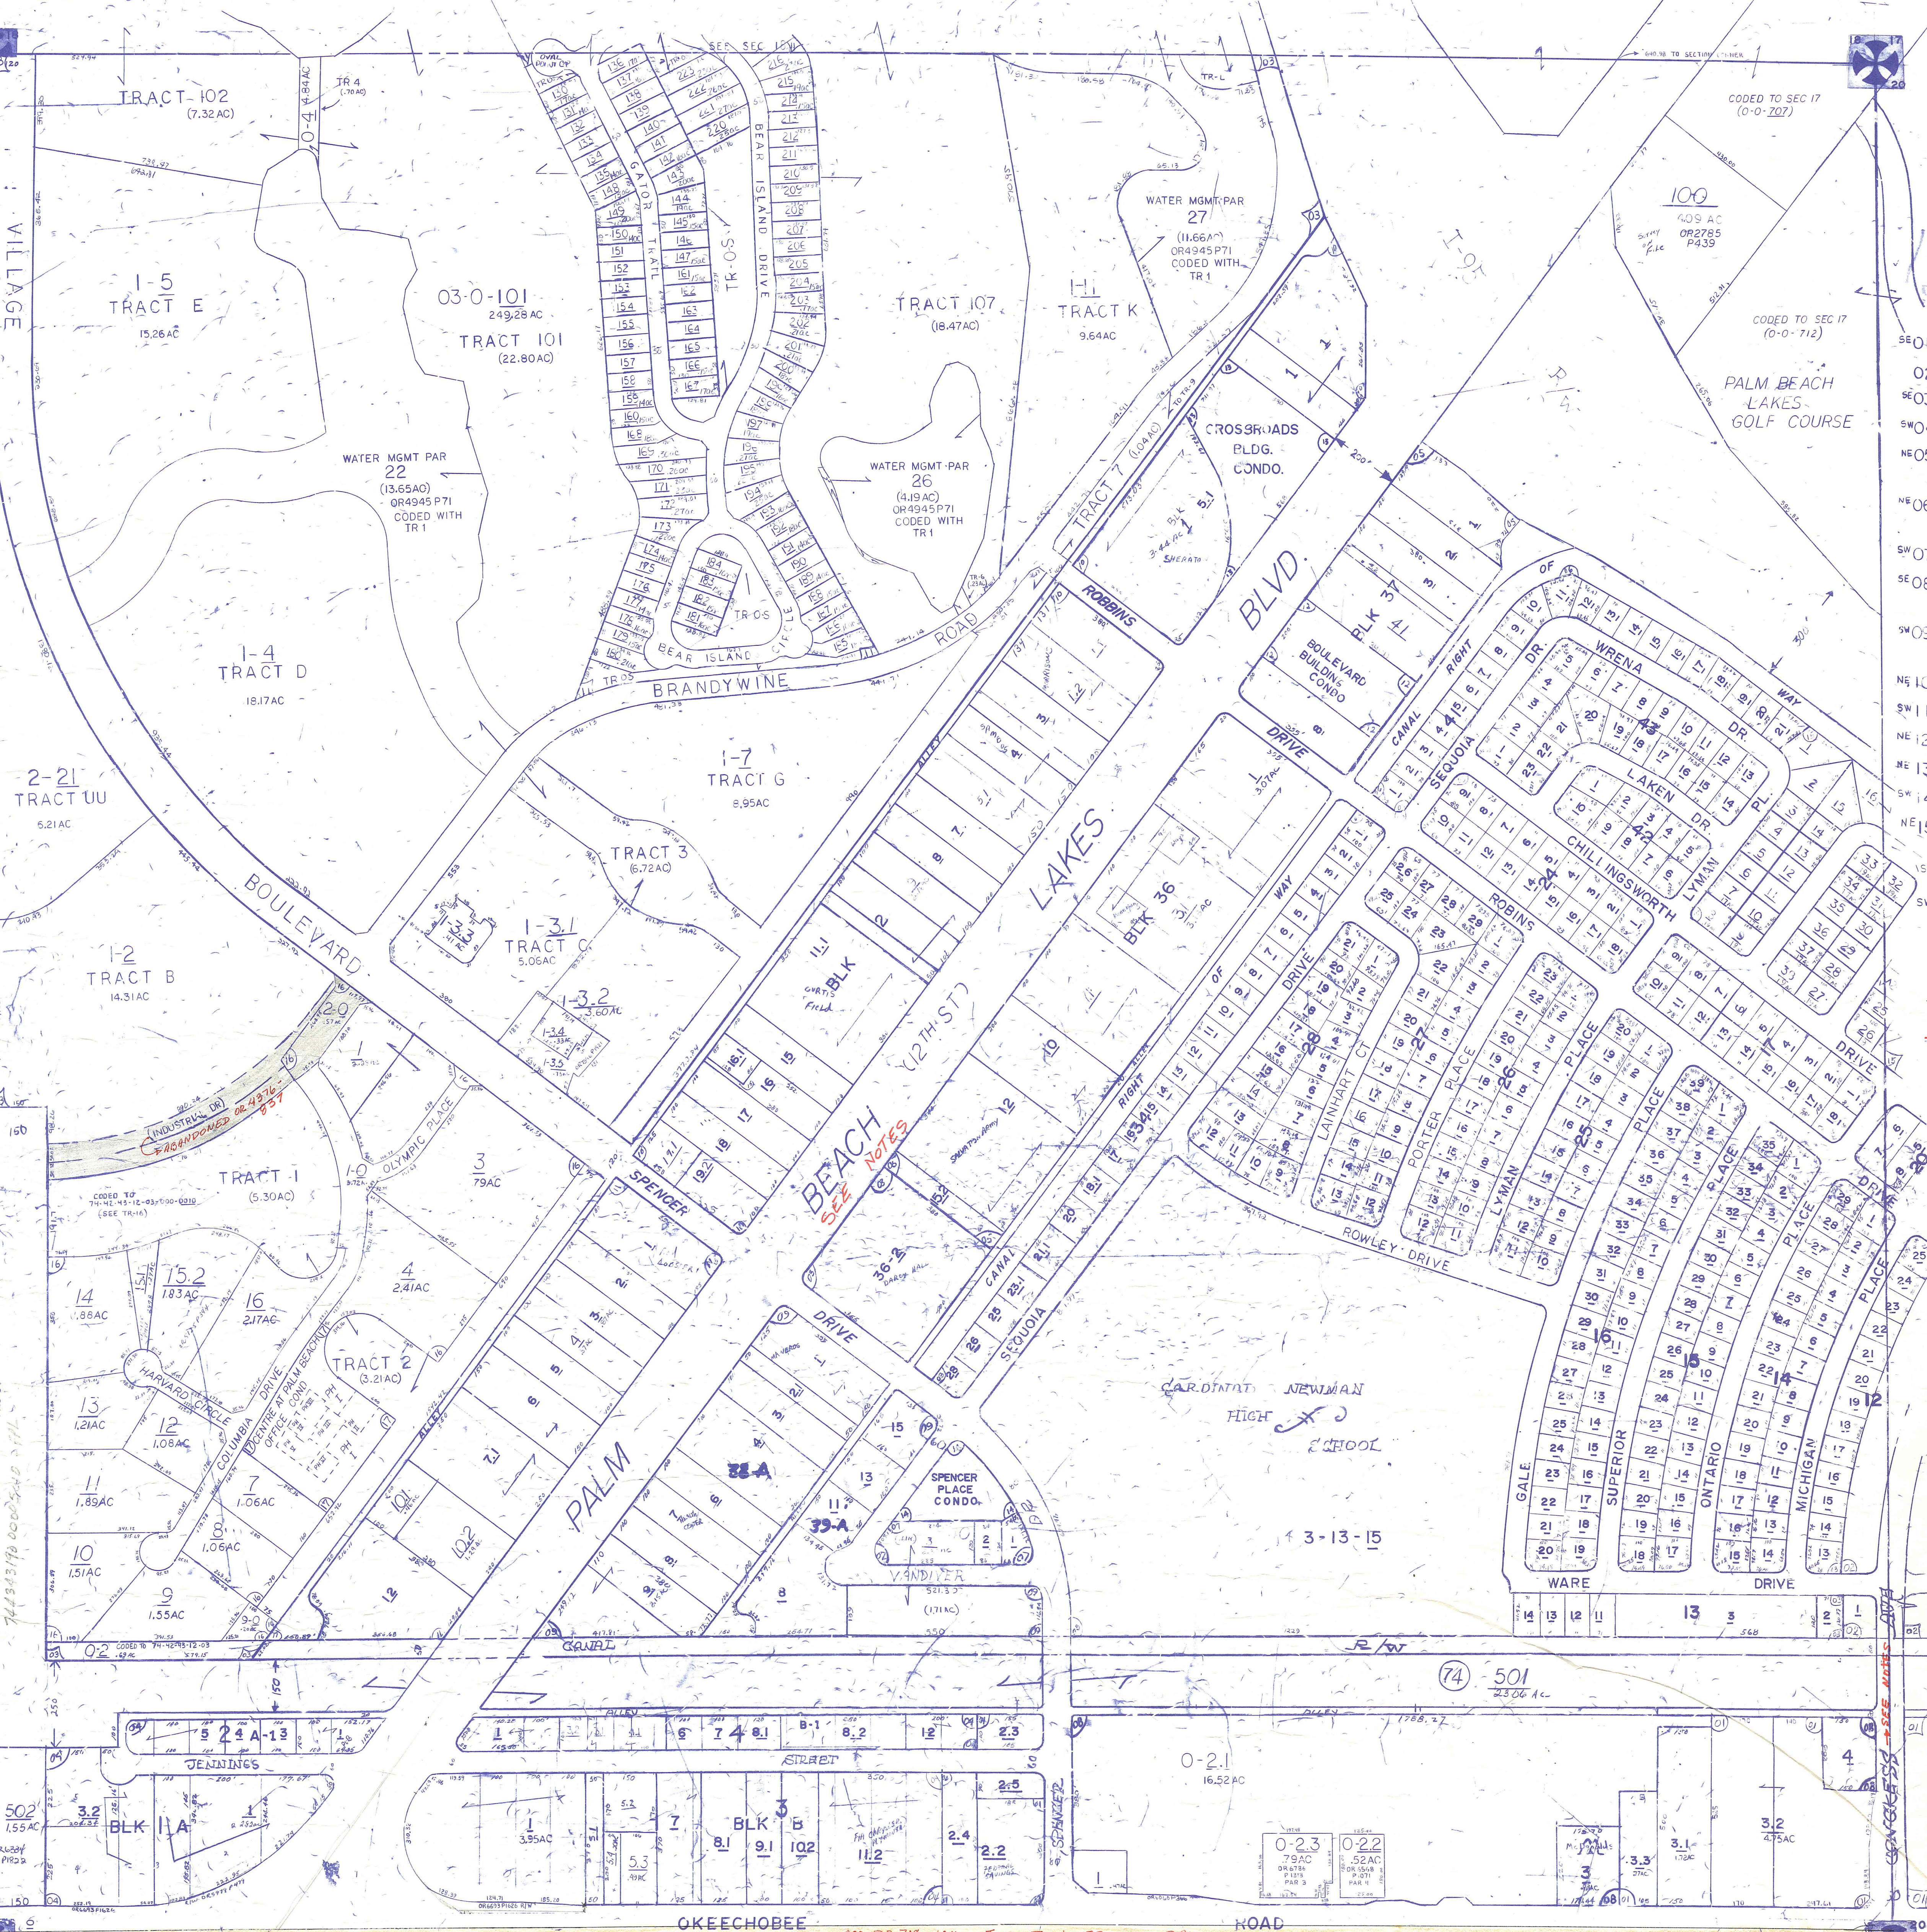


- SE01 PERINI WESTWARD COMM. AREA PB 26-152
- 02 PALM BEACH LAKES SO. PB 26-98-97
- SE03 " " " " PL 2 PB 26-153-157
- SW04 OKEECHOBEE RD COMM. AREA PB 28-30
- NE05 PALM BCH LAKES SO REPL OF BLKS 36 & 37 PB 28-93
- NE06 " " " " NO 2 REPL OF BLKS 18, 19, 21, 22 & 23 PB 23-125
- SW07 PALM BCH LAKES SO PL 3 PB 28-105
- SE08 PERINI WESTWARD COMM. AREA REPL OF TR 6, 7, 8, 99, 100 PB 28-170
- SW09 PALM BEACH LAKES SO REPL OF BLKS 38-39 PB 28-180
- NE10 " " " " COMM. NO 1 PB 28-250
- SW11 " " " " NO 3 PB 29-42
- NE12 BOULEVARD BUILDING CONDO (1978)
- NE13 CROSSROADS BLDG CONDO (1978)
- SW14 SPENCER PLACE CONDO (1978)
- NE15 PALM BEACH LAKES SOUTH REPL TR 1 (1984) PB 45P-117
- SW16 VILLAGE COMMERCE CENTER PB 52 PG (86)
- SW17 CENTRE AT PALM BEACH OFFICE CONDO (1989)

NOTES

- PALM BEACH LAKES BLVD: FROM OKEECHOBEE TO DRIVE HWY
- CONGRESS AVE: FROM OKEECHOBEE TO 45TH ST.
- SEE RES 85-1067 FOR AGREEMENT BETWEEN P.B.C. & CITY OF W.P.B. TRANSFERRING TO COUNTY ENGINEERING SERVICES AND RESPONSIBILITIES WITHIN THE MUNICIPAL BOUNDARIES OF CITY OF W.P.B.

DDC NO. 59 NEW (1972)

NOTE: ALL OF SEC. 19 TWP. 43 RGE. 43 IS WITHIN MUN. OF W.P.B. CODED (74)

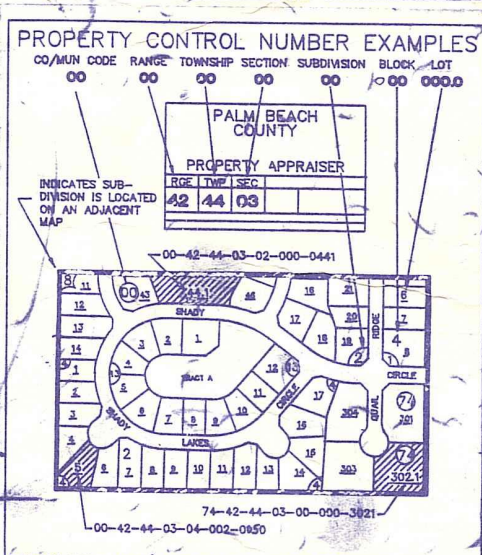

NOTE:
NOT TO BE REPRODUCED IN ANY FORM EXCEPT BY EXPRESS WRITTEN CONSENT FROM THE PALM BEACH COUNTY ASSESSOR.
Information shown hereon is compiled from the best available sources and CANNOT be used for surveys or land transfers of any type.

SEE ALSO SEC 2 FOR SUB 01

Palm Beach County (County) makes no representation or warranties whatsoever on the attached / enclosed information reflected herein pertaining to easements, rights-of-way, setback lines, reservations, agreements, and other similar matters. The information provided herein should not be relied upon by the requesting party to confirm the existence / non-existence of facts contained herein.

PALM BEACH COUNTY
GARY R. NIKOLITS
PROPERTY APPRAISER

RGE	TWP	SEC	BLK	PL
43	43	19		NOTED
SCALE	1" = 200'			
DRAWN BY	G. R. Nikolits			
UPDATED	5-18-74			