

17


PLAT OF IRWINAIRE

IN 2 SHEETS SHEET NO. 2

NOVEMBER - 1974

AMENDED PLAT OF FLA-MANGO GROVELETS P.B. 21 PG. 88



AMENDED PLAT OF FLA-MANGO GROVELETS P.B. 21 PG. 88

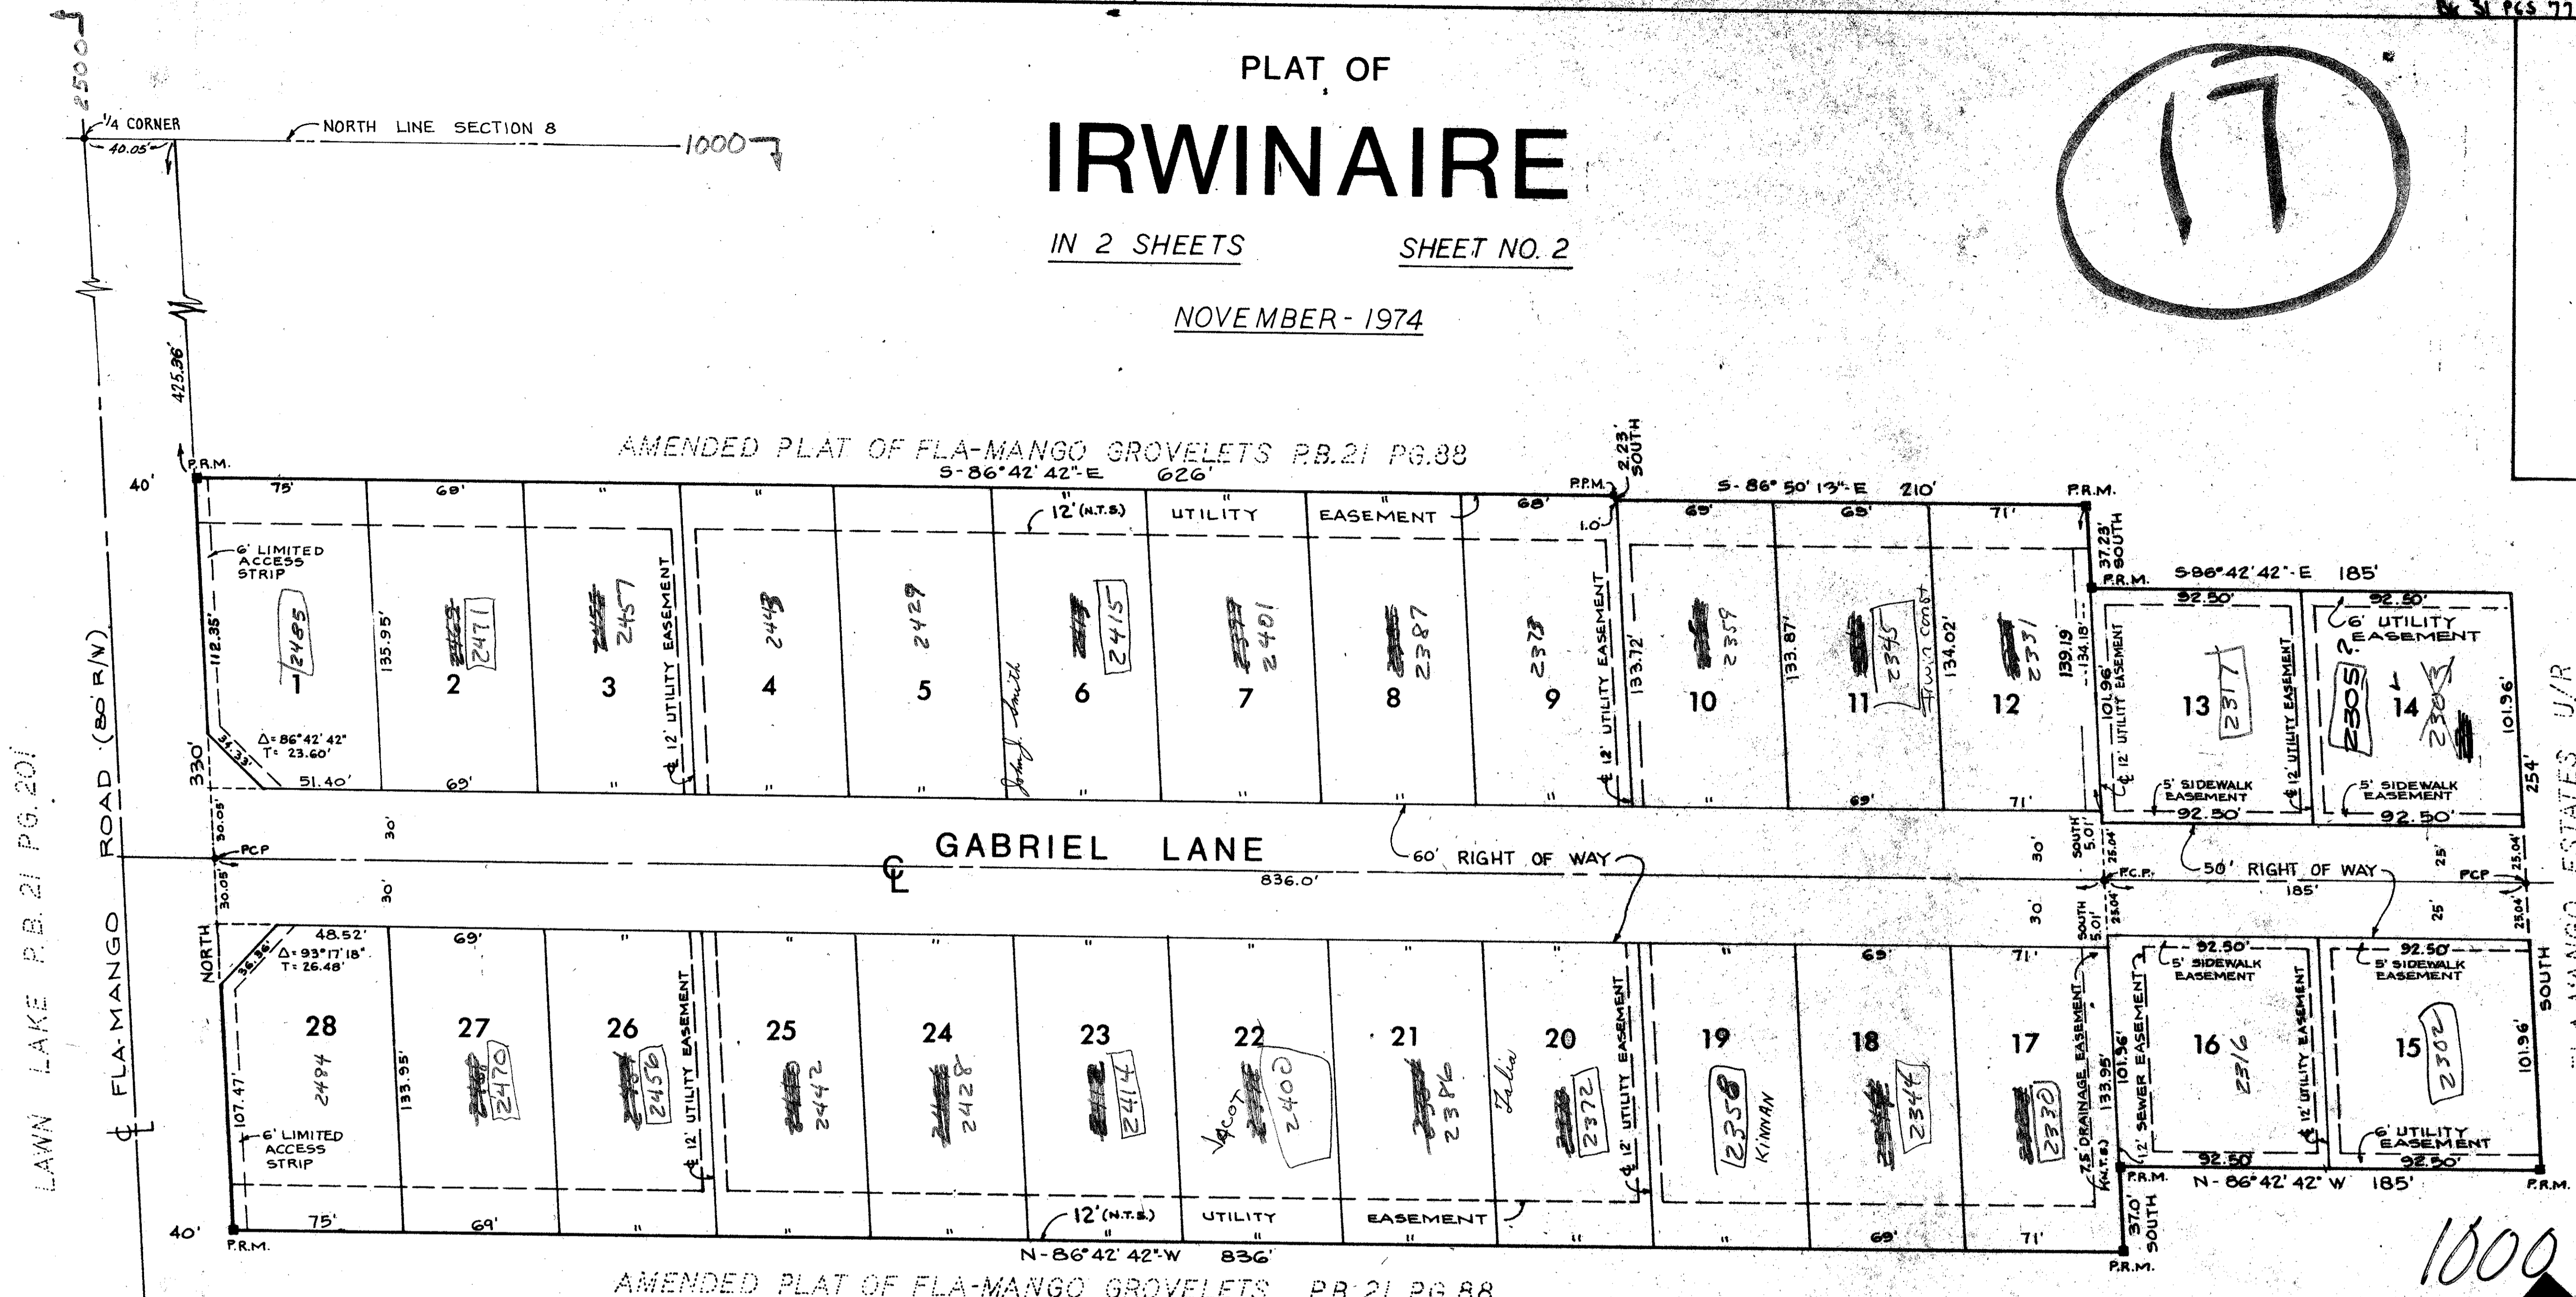

LAWN LAKE P.B. 21 PG. 201

FLA-MANGO ESTATES U/R

- NOTES:
- 1.) ALL BEARINGS SHOWN HEREON ARE TO AN ASSUMED DATUM
 - 2.) ■ DENOTES PERMANENT REFERENCE MONUMENT (P.R.M.) SET
 - 3.) ● DENOTES PERMANENT CONTROL POINT SET (P.C.P.)
 - 4.) THERE SHALL BE NO BUILDINGS OR ANY TYPE OF CONSTRUCTION OR THE PLANTING OF TREES OR SHRUBS ON OR UTILITY EASEMENTS.

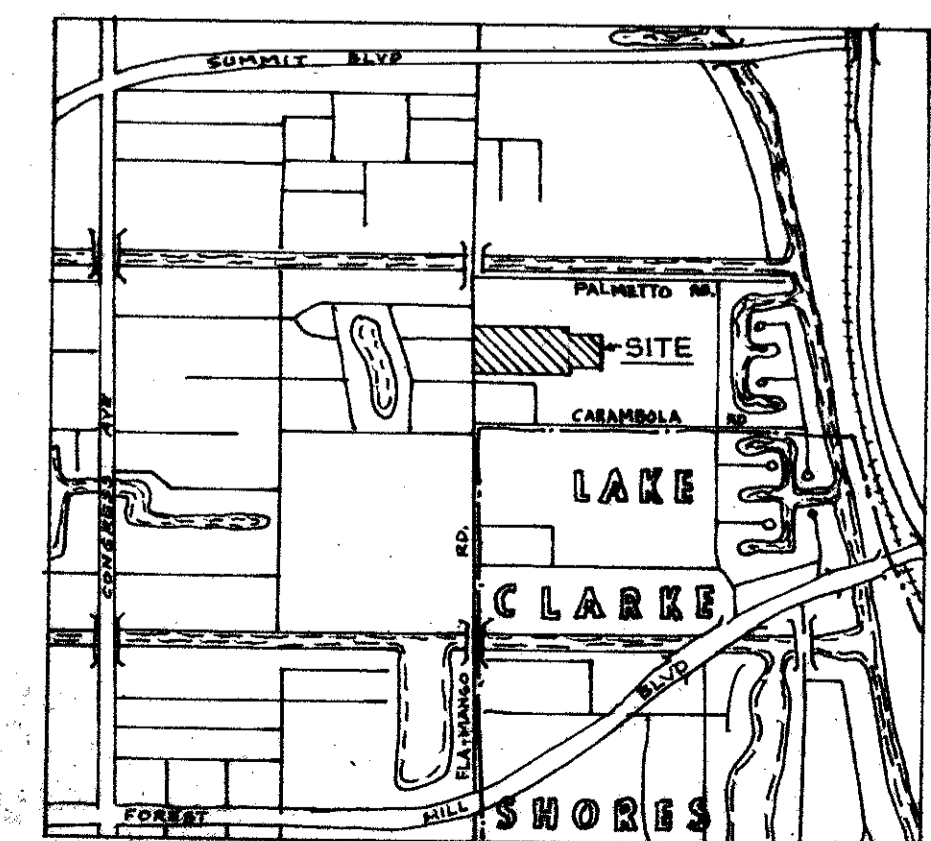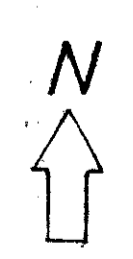


VICINITY MAP NO SCALE

1000-178



31/18

TURNOUT REQUIRED
SIDEWALK REQUIRED

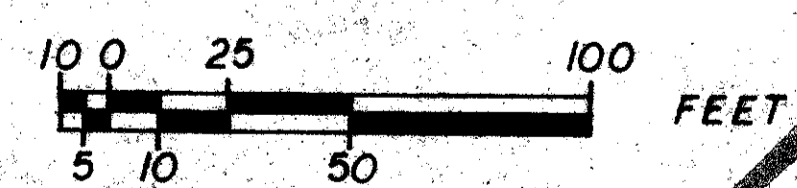

GRAPHIC SCALE
1" = 40'

THIS INSTRUMENT PREPARED BY:
WILLIAM A. CURTIS
2750 OKEECHOBEE BOULEVARD
WEST PALM BEACH, FLORIDA

IRWINAIRE

IRWINAIRE

JAMES D. CARLTON, INC.

DATE:	DWN:	CHK:	SCALE:	SHEET:
11-12-74	WAC	DDC	1" = 40'	2 OF 2